

FALCONI COMPANIES  
524-530 ADAMS ST  
MILTON MA.

SEE SHEET A1 FOR DRAWING INDEX

IF PRINTED ON 11X17, ALL SCALE IS HALF.

PLEASE REFER TO ENGINEERING PACKET  
FOR ALL STRUCTURAL DETAILS

OWNER:


FALCONI COMPANIES  
524-530 ADAMS ST  
MILTON, MA 02168

REVISION 1:  
1-5-2021- SITE VISIT-  
EXISTING CONDITIONS

DESIGNER:


ROCKWOOD DESIGN, INC.  
1020 PLAIN STREET - SUITE 320  
MARSHFIELD, MA 02050  
PHONE: (781)-837-3140  
FAX: (781)-837-3126  
EMAIL: DICK@ROCKWOODDESIGN.COM  
WEBSITE: WWW.ROCKWOODDESIGN.COM

STRUCTURAL  
ENGINEER:

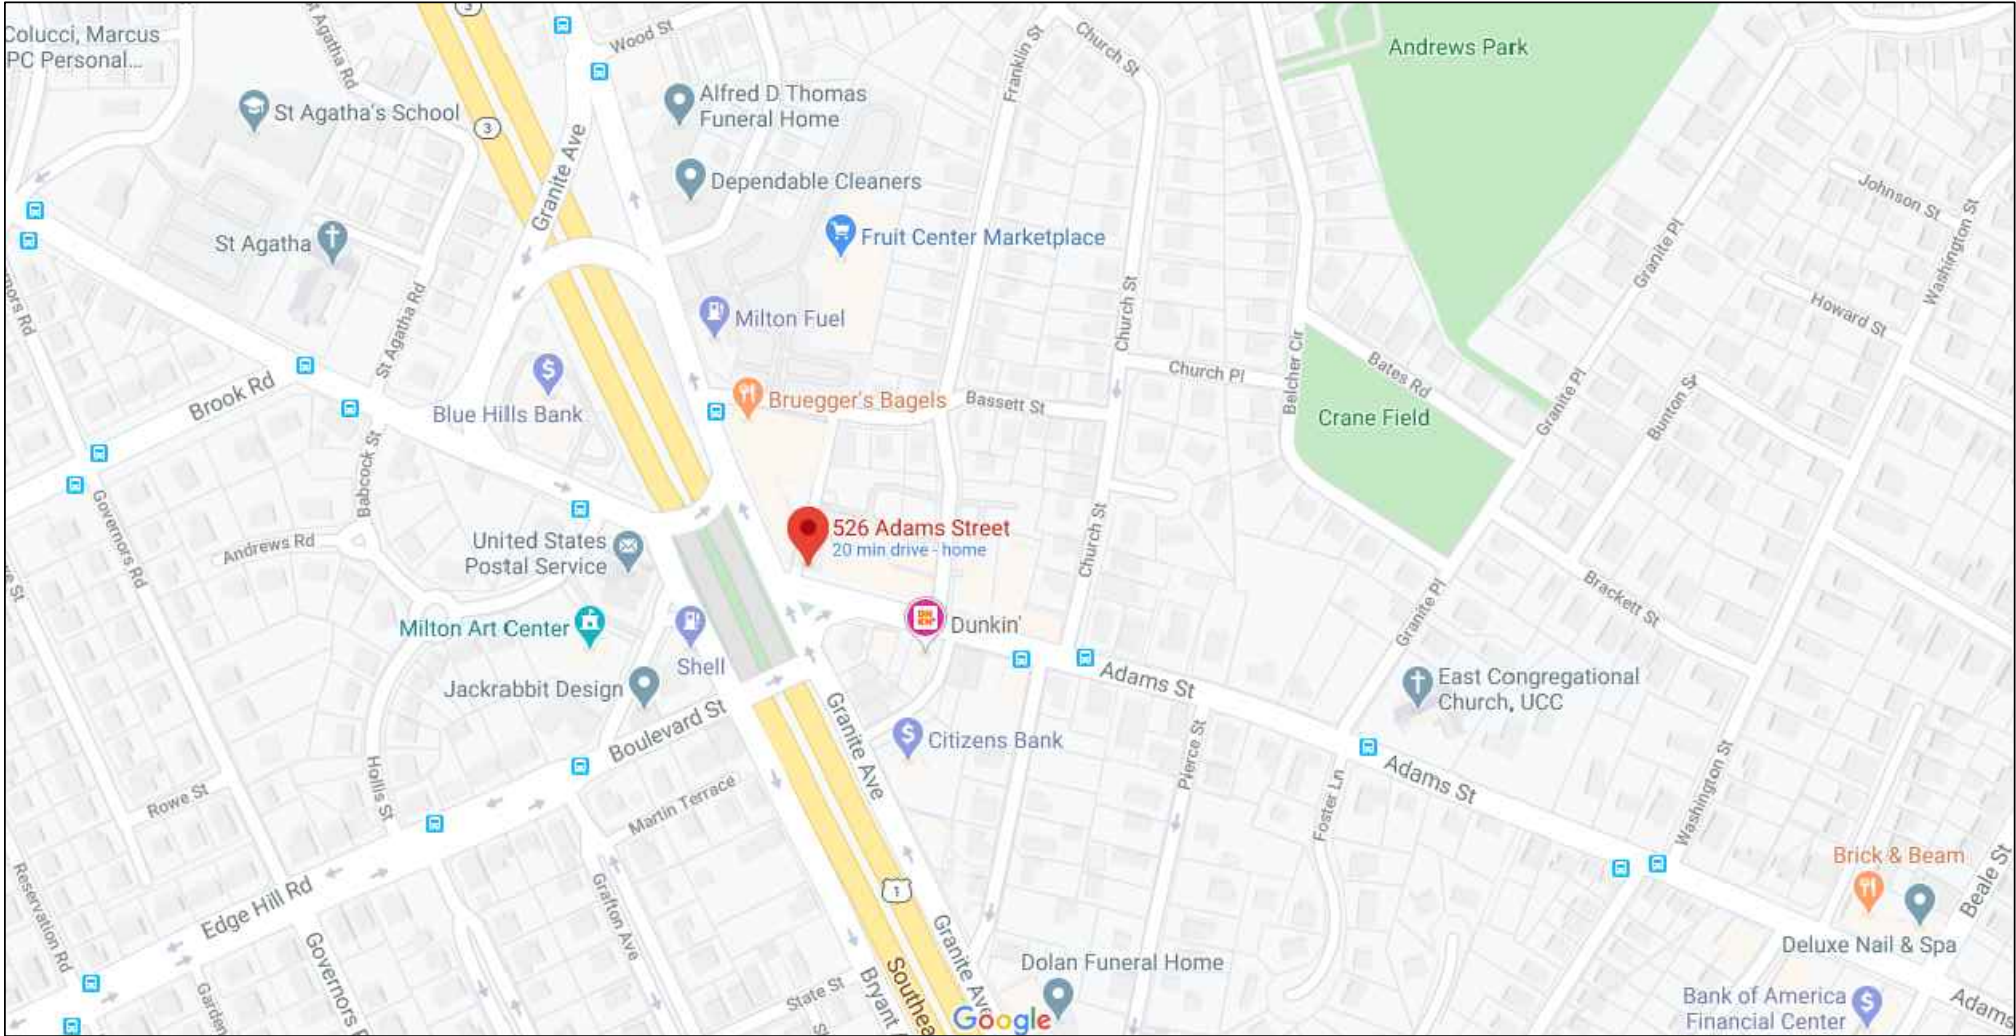

LOCUS MAP

AAB SUBMITTAL SET 5-5-2021

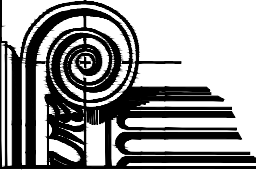

Rockwood  
Design, Inc.

1020 Plain Street - Suite 320  
Marshfield, MA 02050  
Phone: (781)-837-3140  
Fax: (781)-837-3126  
Email: dick@rockwooddesign.com  
Website: www.rockwooddesign.com

SEE SHEET AI FOR DRAWING INDEX



**LIGHT FIXTURE SCHEDULE**

FX1: HINKLEY 2195BZ - LED/BRONZE  
FX2: RIPLEY 4906002 BRONZE  
FX3: WP LED 80 BRONZE

ANY DEVIATION FROM THESE PLANS  
REQUIRING ROCKWOOD DESIGN INC.  
TO ACQUIRE STRUCTURAL REDESIGN FOR  
BUILDING DEPARTMENT SIGN-OFFS WILL BE  
BILLED TO CLIENT ON AN HOURLY BASIS.

AAB SUBMITTAL SET 5-5-2021

## A2.1

PROJECT:  
FALCONI COMPANIES  
524-530 ADAMS STREET  
MILTON, MA. 02186

**Rockwood  
Design, Inc.**  
1020 Plain Street - Suite 320  
Marshallfield, MA 02050  
Phone: (781)-837-3140  
Fax: (781)-837-3126  
Email: [dick@rockwooddesign.com](mailto:dick@rockwooddesign.com)  
Website: [www.rockwooddesign.com](http://www.rockwooddesign.com)


DATE:  
5/5/2021

DRAWN BY:  
TJM

CHECKED BY:

SCALE:  
AS SHOWN


COPYRIGHT © 2019 BY ROCKWOOD DESIGN, INC. THE ARCHITECTURAL PLANS, DRAWINGS, DESIGNS, SPECIFICATIONS AND OTHER ARRANGEMENTS ON THIS SHEET ARE AND SHALL REMAIN THE PROPERTY OF ROCKWOOD DESIGN, INC. NO PART THEREOF SHALL BE COPIED, DISCLOSED TO OTHERS, OR USED IN CONNECTION WITH ANY WORK OR PROJECT, OTHER THAN THE SPECIFIED PROJECT FOR WHICH THEY HAVE BEEN PREPARED AND DEVELOPED, WITHOUT THE EXPRESS KNOWLEDGE AND WRITTEN CONSENT OF ROCKWOOD DESIGN, INC.

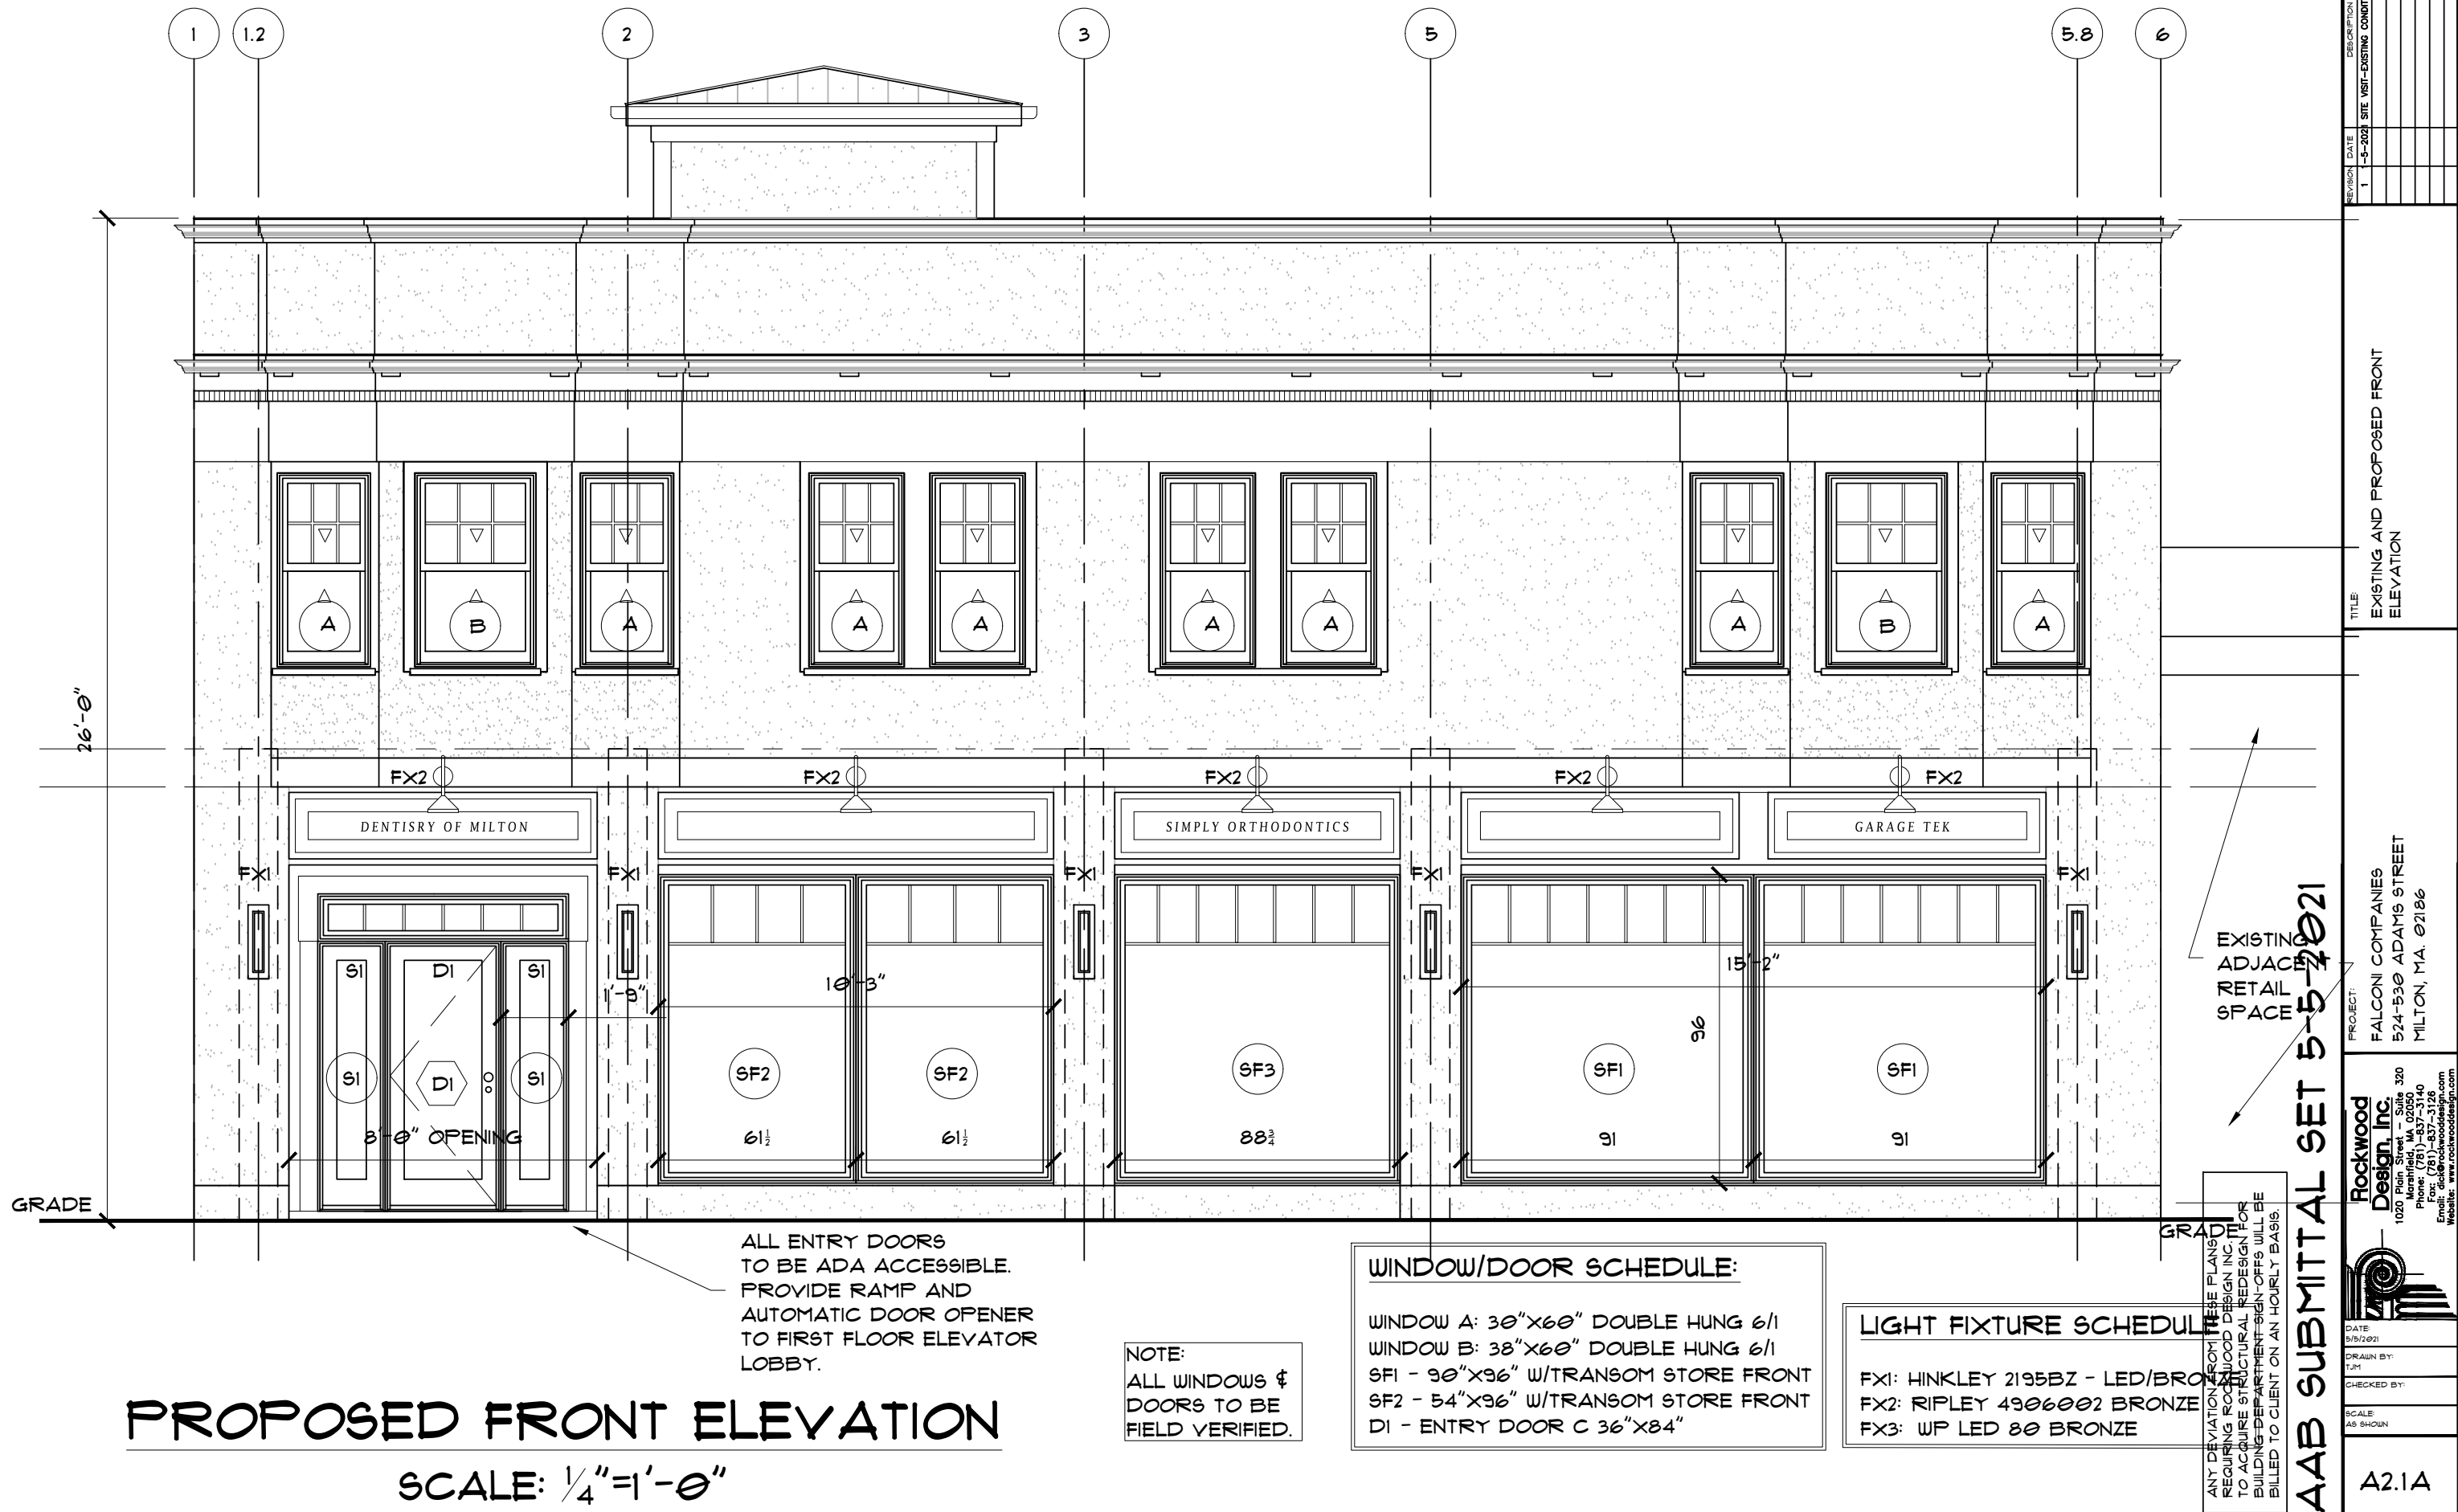


PLEASE REFER TO ENGINEERING PACKET  
FOR ALL STRUCTURAL DETAILS

IF PRINTED ON 11X17, ALL SCALE IS HALF.

SEE SHEET A1 FOR DRAWING INDEX

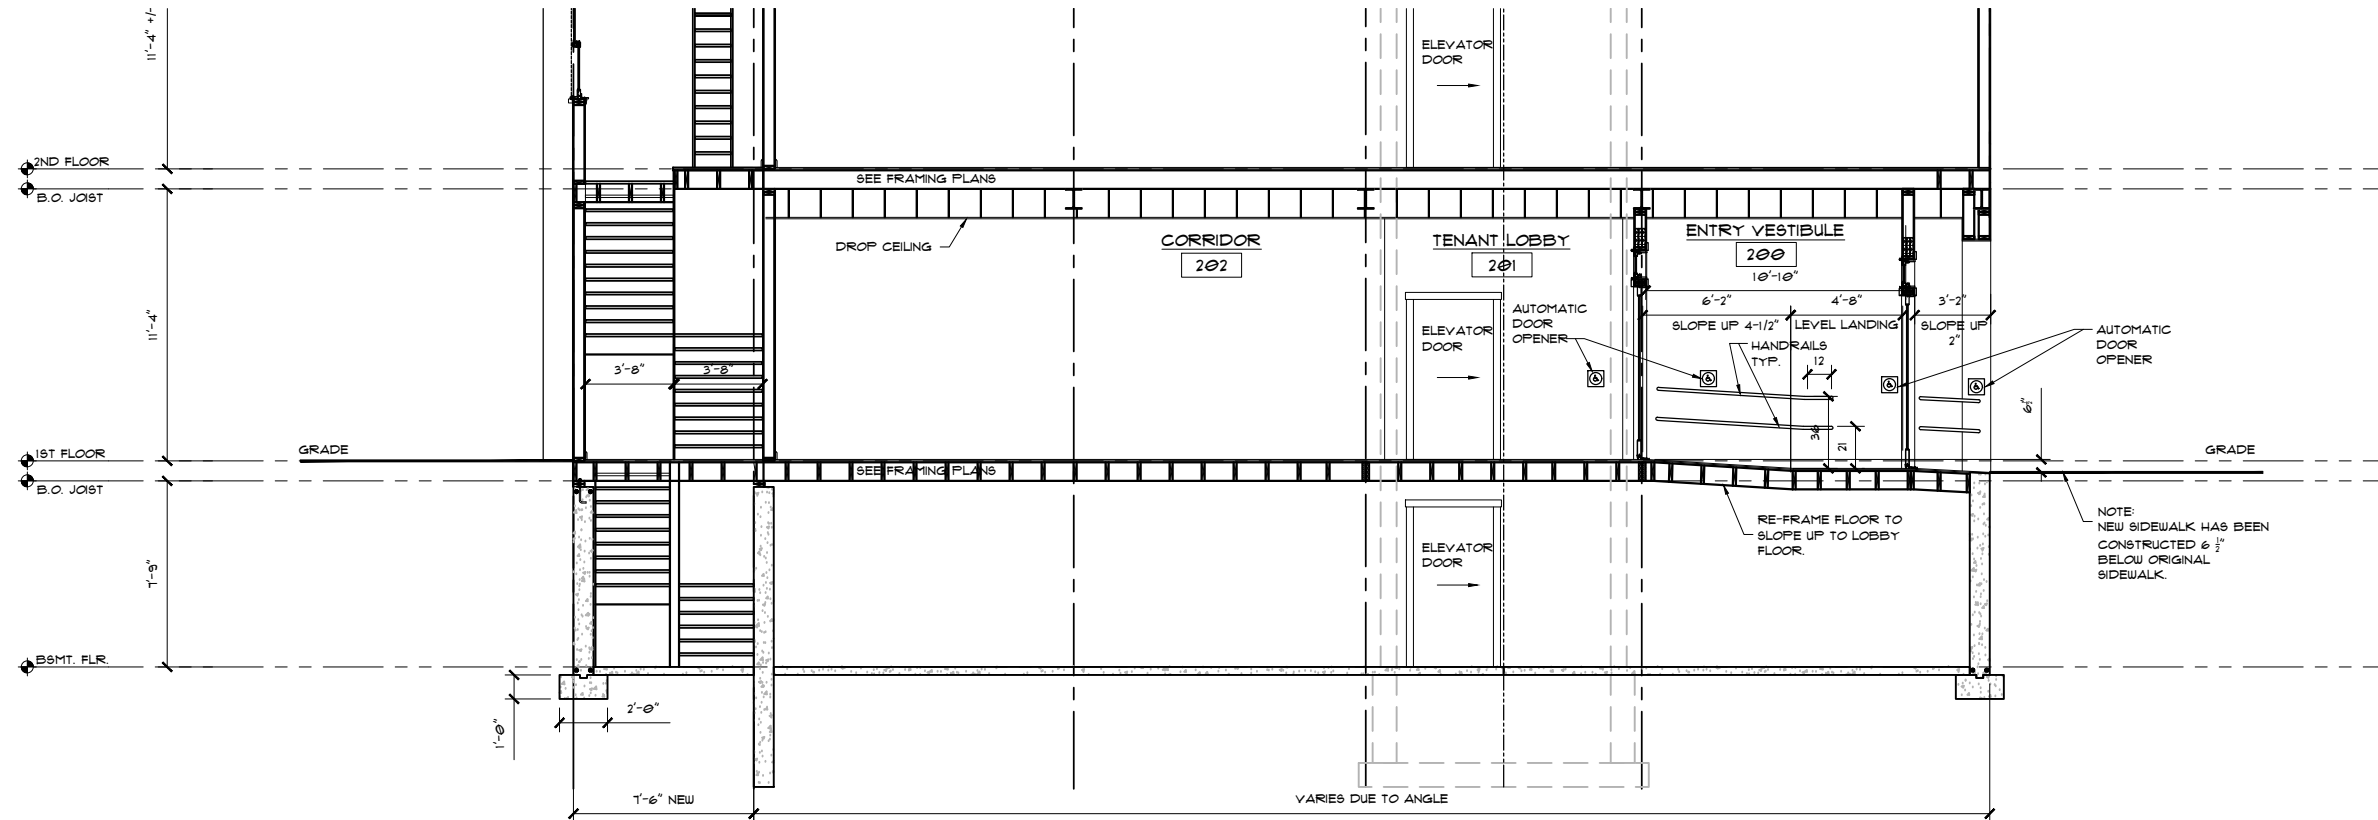

OPTION A BUILDING SECTION  
ENTRY SIDEWALK RAMP  
SCALE: 1/4"=1'-0"

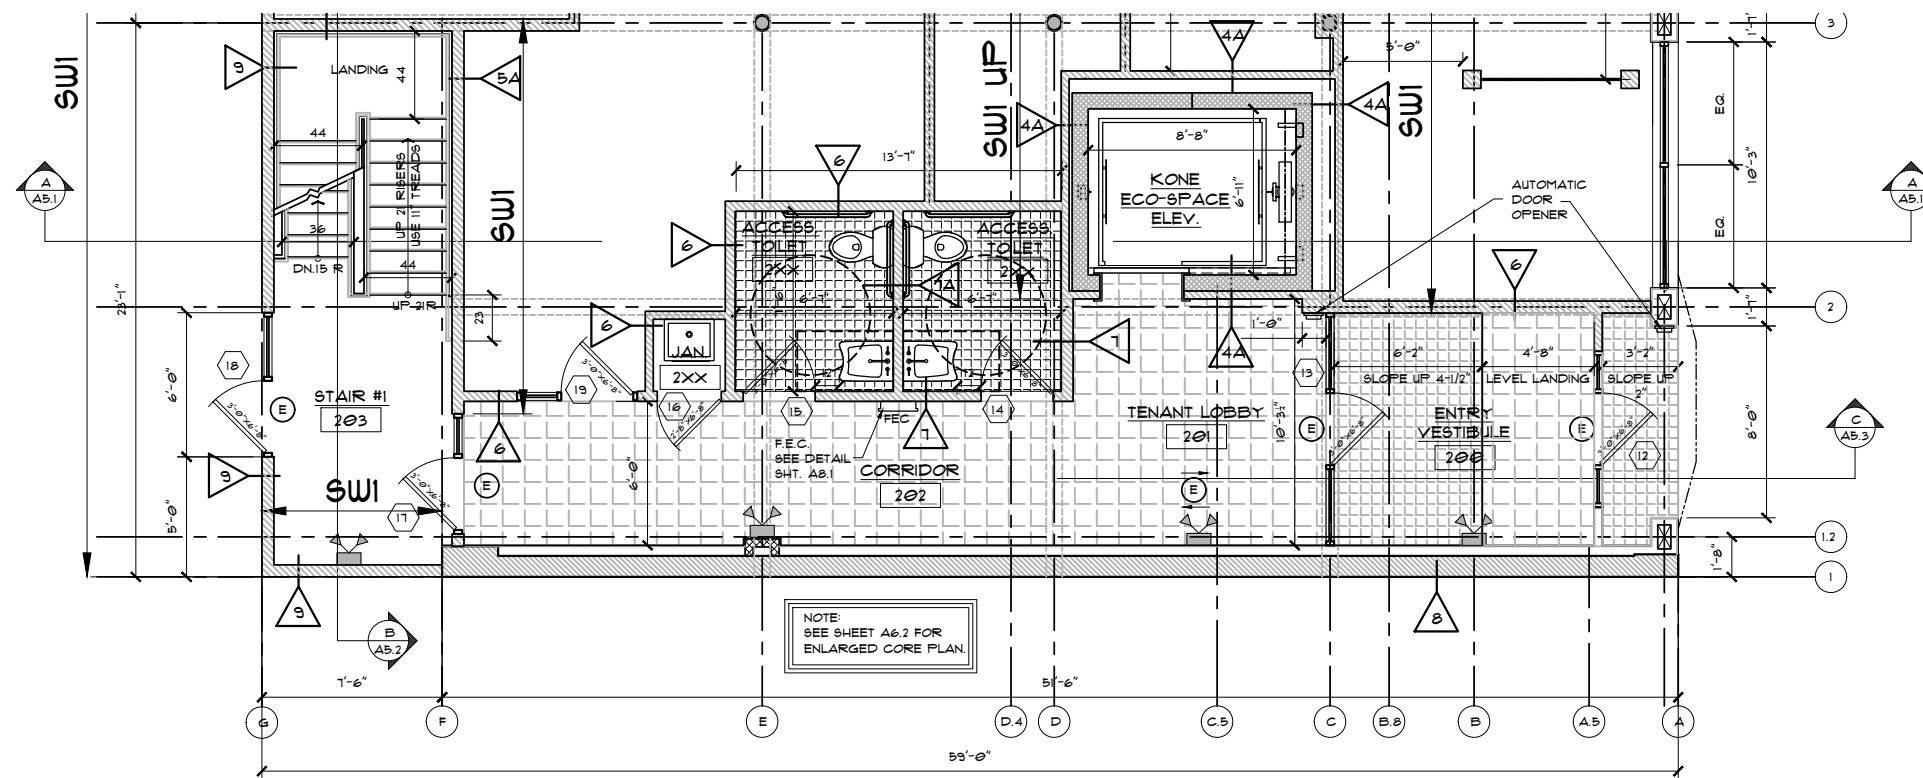

PROPOSED ENTRY OPTION A  
SCALE: 1/4"=1'-0"

ANY DEVIATION FROM THESE PLANS  
REQUIRING ROCKWOOD DESIGN INC.  
TO ACQUIRE STRUCTURAL REDESIGN FOR  
BUILDING DEPARTMENT SIGN-OFFS WILL BE  
BILLED TO CLIENT ON AN HOURLY BASIS.

AAB SUBMITTAL SET 5-5-2021

| REVISION | DATE     | DESCRIPTION                              |
|----------|----------|------------------------------------------|
| 1        | 5-5-2021 | SITE VISIT-EXISTING CONDITIONS CONFIRMED |

TITLE  
PROPOSED OPTION A

PROJECT:  
FALCONI COMPANIES  
524-530 ADAMS STREET  
MILTON, MA 02186

Rockwood  
Design, Inc.  
1020 Plain Street - Suite 320  
Methen, MA 02050  
Phone: (781)-837-3140  
Fax: (781)-837-3126  
Email: info@rockwooddesign.com  
Website: www.rockwooddesign.com



DATE  
5/5/2021

DRAWN BY:  
TJM

CHECKED BY:

SCALE  
AS SHOWN


A4.1

OF 1


PLEASE REFER TO ENGINEERING PACKET  
FOR ALL STRUCTURAL DETAILS

IF PRINTED ON 11X17, ALL SCALE IS HALF.

SEE SHEET A1 FOR DRAWING INDEX

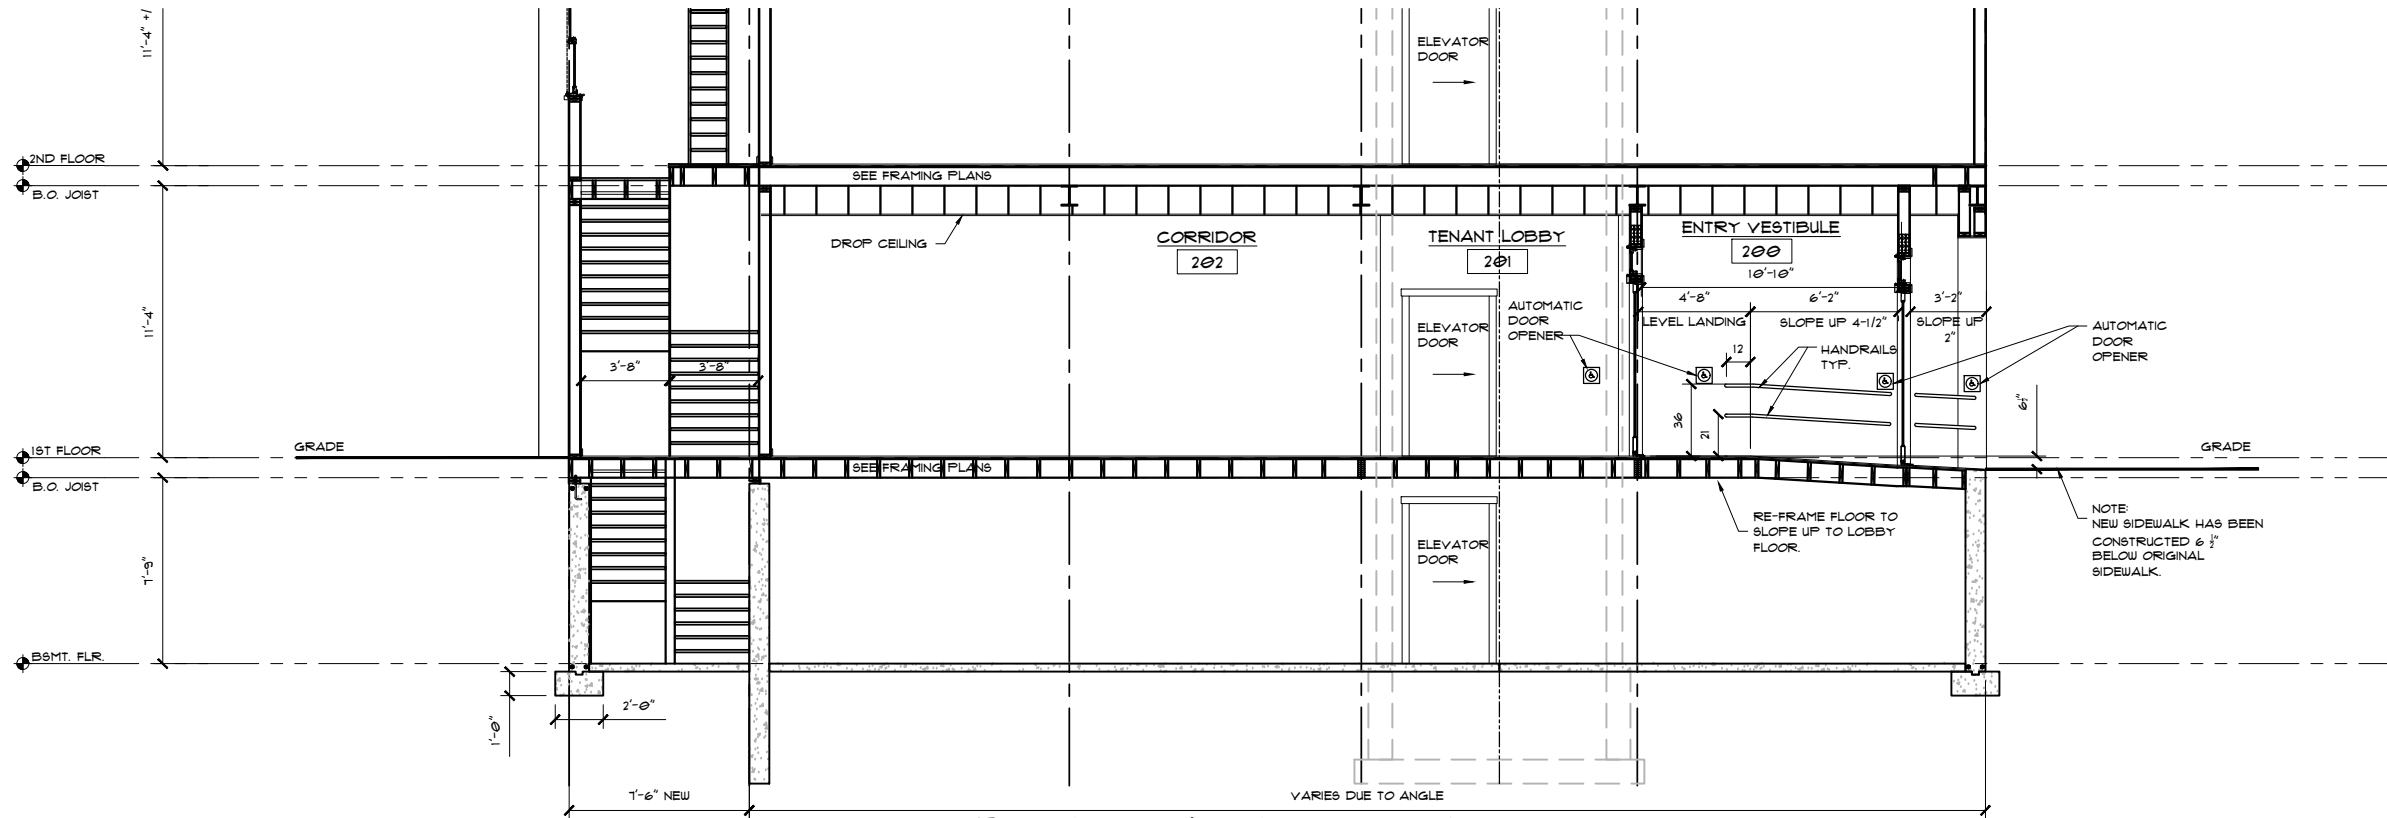

OPTION B BUILDING SECTION  
ENTRY SIDEWALK RAMP  
SCALE:  $\frac{1}{4}''=1'-0''$

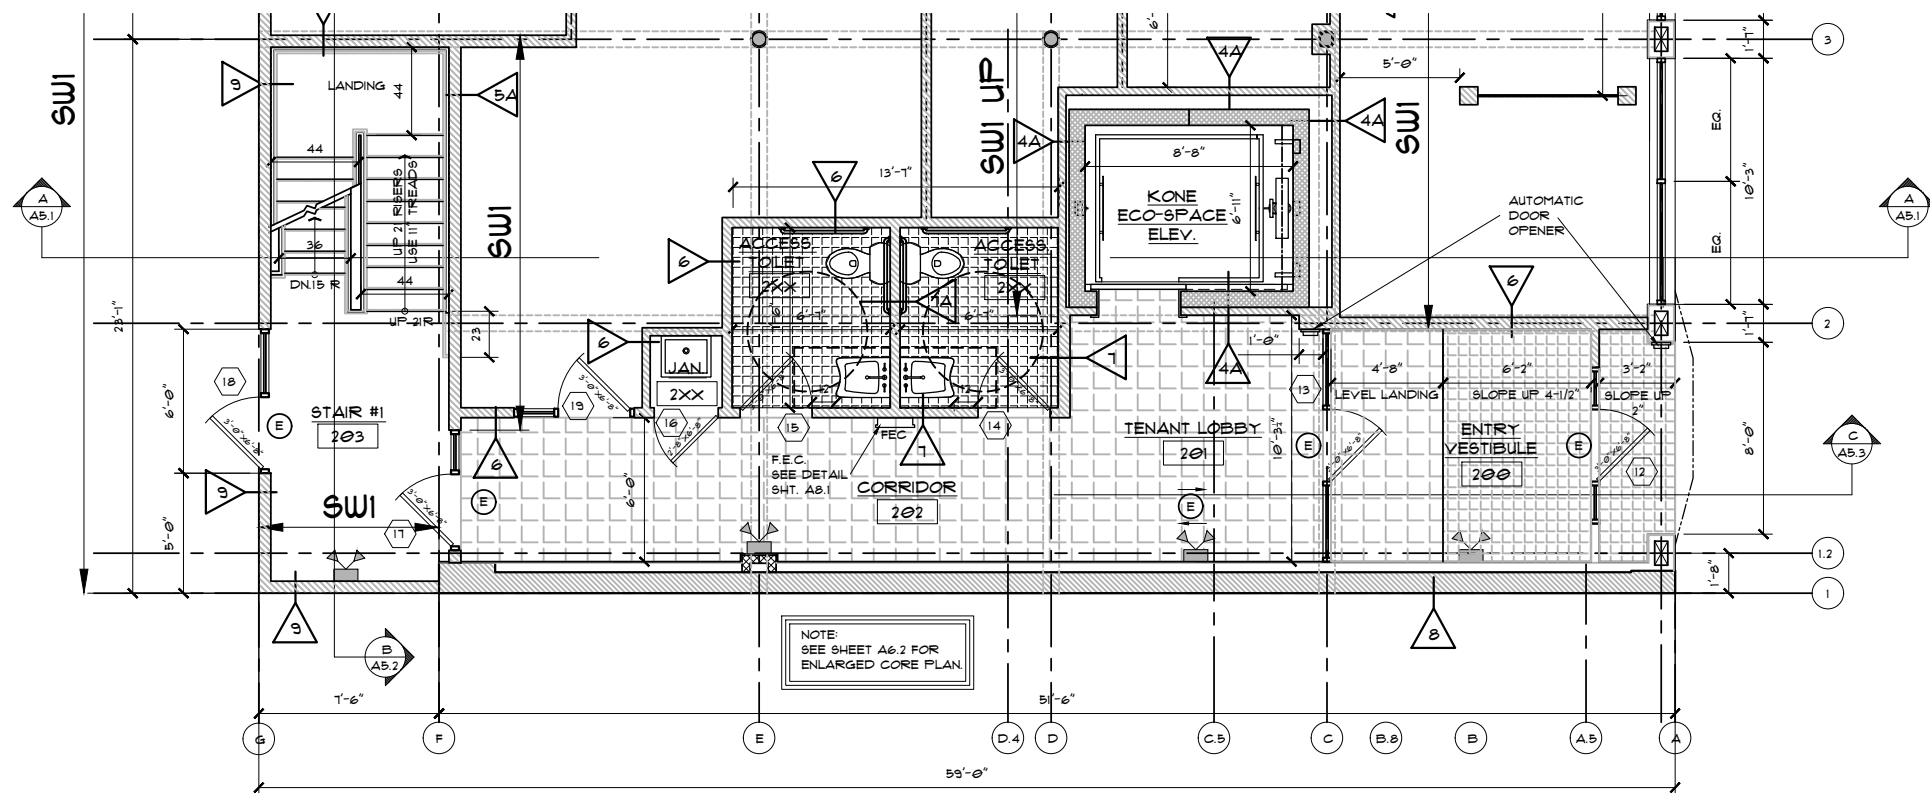

PROPOSED ENTRY OPTION B  
SCALE:  $\frac{1}{4}''=1'-0''$

ANY DEVIATION FROM THESE PLANS  
REQUIRING ROCKWOOD DESIGN INC.  
TO ACQUIRE STRUCTURAL REDESIGN FOR  
BUILDING DEPARTMENT SIGN-OFFS WILL BE  
BILLED TO CLIENT ON AN HOURLY BASIS.

AAB SUBMITTAL SET 5-5-2021

A4.2

PROJECT:  
FALCONI COMPANIES  
524-530 ADAMS STREET  
MILTON, MA 02186

Rockwood  
Design, Inc.  
1020 Plain Street - Suite 320  
Methen, MA 02050  
Phone: (781)-837-3140  
Fax: (781)-837-3126  
Email: info@rockwooddesign.com  
Website: www.rockwooddesign.com

DATE:  
5/5/2021

DRAWN BY:  
TJM

CHECKED BY:

SCALE:  
AS SHOWN


| REVISION | DATE     | DESCRIPTION                              |
|----------|----------|------------------------------------------|
| 1        | 5-5-2021 | SITE VISIT-EXISTING CONDITIONS CONFIRMED |

TITLE:  
PROPOSED OPTION B


PLEASE REFER TO ENGINEERING PACKET  
FOR ALL STRUCTURAL DETAILS

IF PRINTED ON 11X17, ALL SCALE IS HALF.

SEE SHEET A1 FOR DRAWING INDEX

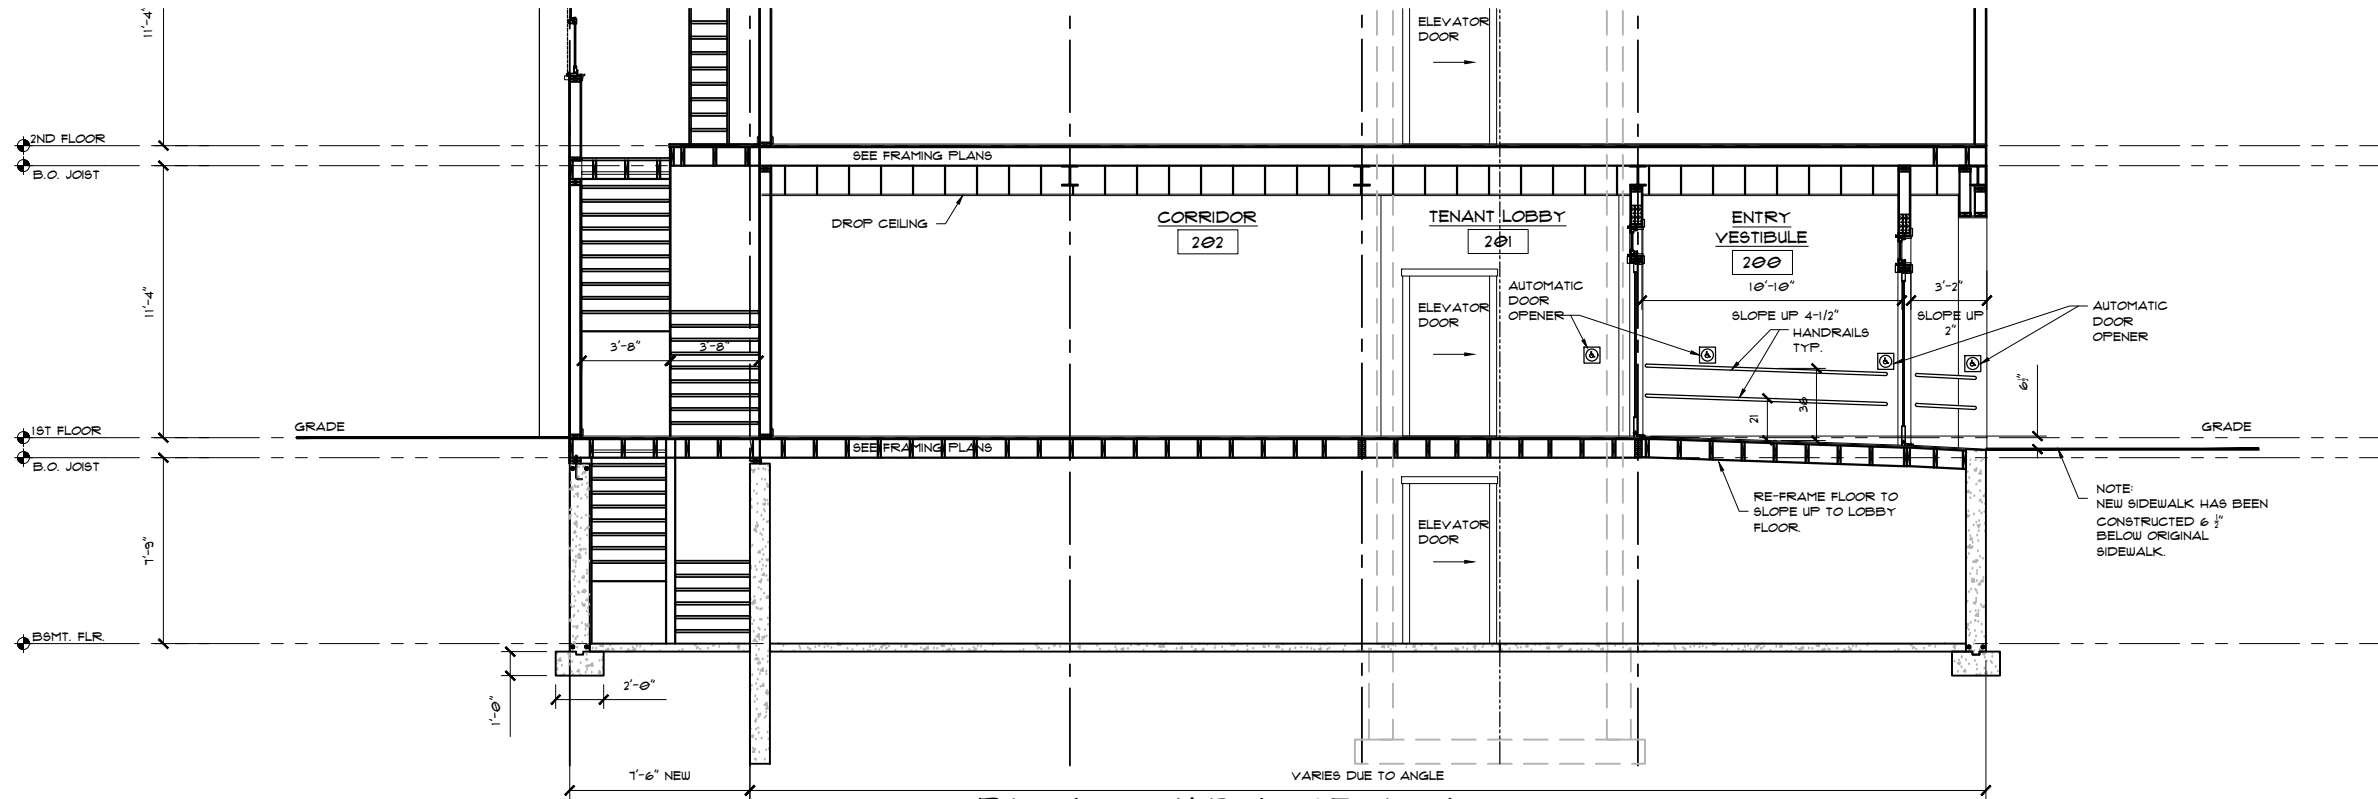

OPTION C BUILDING SECTION  
ENTRY SIDEWALK RAMP  
SCALE: 1/4"=1'-0"

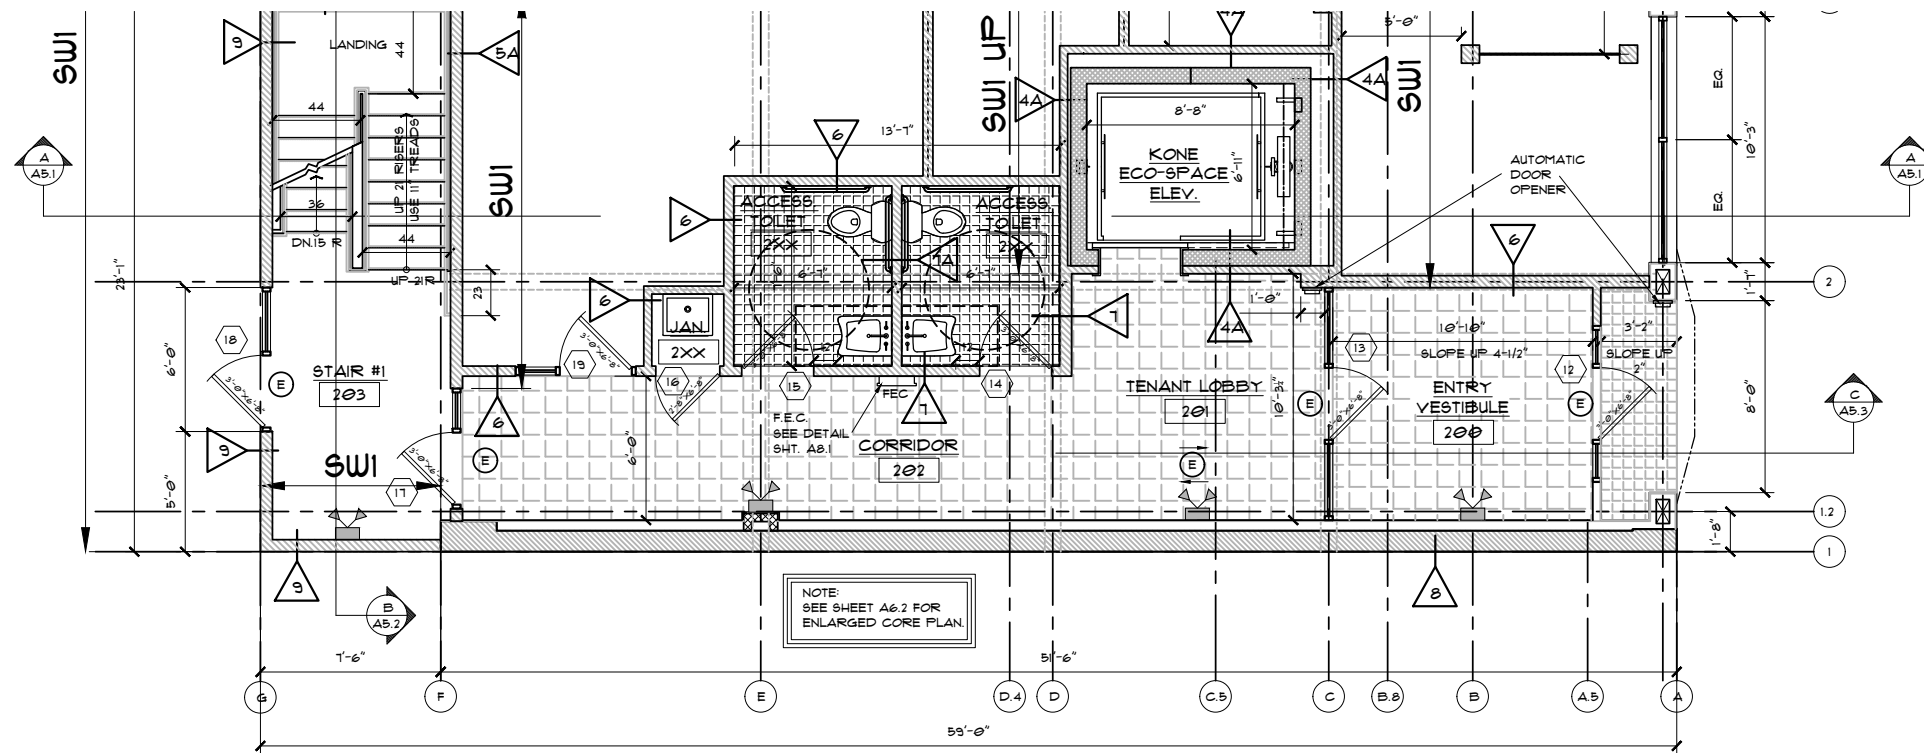

PROPOSED ENTRY OPTION C  
SCALE: 1/4"=1'-0"

ANY DEVIATION FROM THESE PLANS  
REQUIRING ROCKWOOD DESIGN INC.  
TO ACQUIRE STRUCTURAL REDESIGN FOR  
BUILDING DEPARTMENT SIGN-OFFS WILL BE  
BILLED TO CLIENT ON AN HOURLY BASIS.

AAB SUBMITTAL SET 5-5-2021

A4.3

PROJECT:  
FALCONI COMPANIES  
524-530 ADAMS STREET  
MILTON, MA 02186

Rockwood  
Design, Inc.  
1020 Plain Street - Suite 320  
Malden, MA 02148  
Phone: (781)-837-3140  
Fax: (781)-837-3126  
Email: info@rockwooddesign.com  
Website: www.rockwooddesign.com

DATE:  
5/5/2021  
DRAWN BY:  
TJM  
CHECKED BY:  
SCALE:  
AS SHOWN

| REVISION | DATE     | DESCRIPTION                              |
|----------|----------|------------------------------------------|
| 1        | 5-5-2021 | SITE VISIT-EXISTING CONDITIONS CONFIRMED |

TITLE:  
PROPOSED OPTION C