


600 Canton Avenue
MILTON, MA

600 Canton Avenue
MILTON, MA

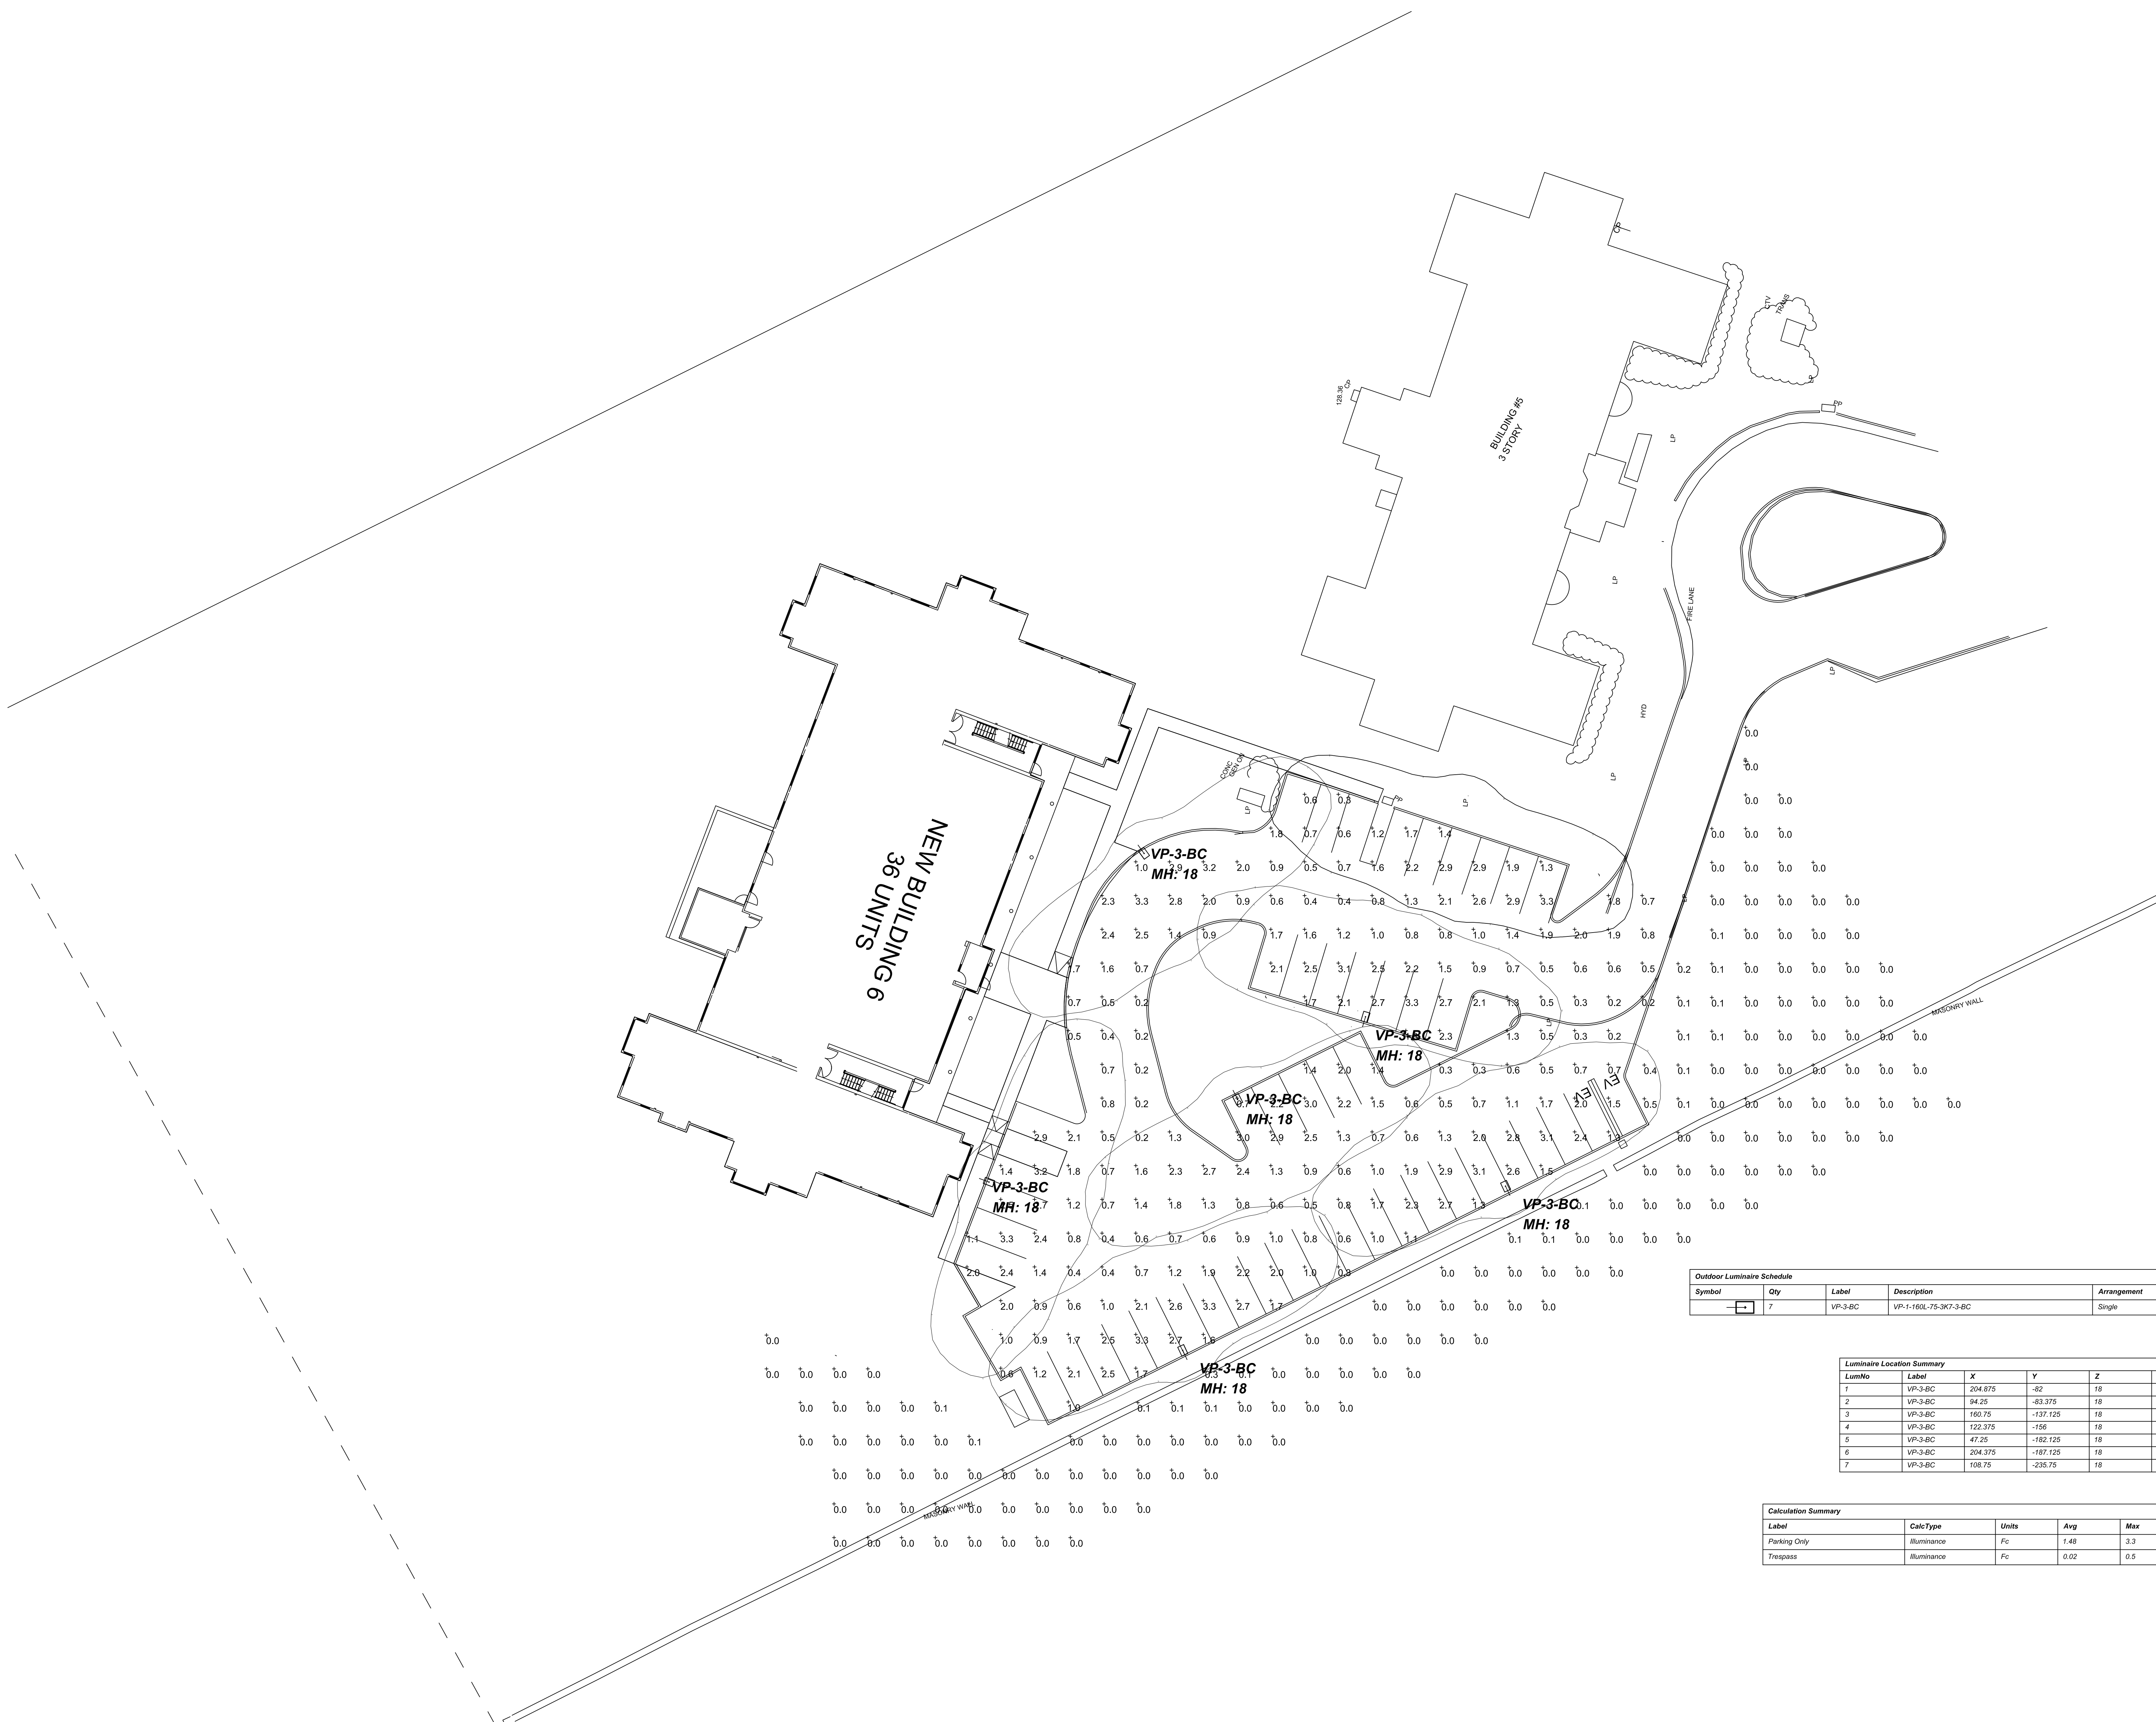

Outdoor Luminaire Schedule							
Symbol	Qty	Label	Description	Arrangement	Arm	Lum. Lumens	LLF
	7	VP-3-BC	VP-1-160L-75-3K7-3-BC	Single	1.5	5848	0.900

Luminaire Location Summary						
LumNo	Label	X	Y	Z	Orient	Titl
1	VP-3-6C	204.875	-82	18	252.865	0
2	VP-3-6C	94.25	-83.375	18	305.904	0
3	VP-3-6C	160.75	+137.125	18	73.396	0
4	VP-3-6C	122.375	+156	18	296.779	0
5	VP-3-6C	47.25	-182.125	18	338.741	0
6	VP-3-6C	204.375	-187.125	18	115.145	0
7	VP-3-6C	108.75	-235.75	18	115.145	0

Calculation Summary							
Label	CalcType	Units	Avg	Max	Min	Avg/Min	Max/Min
Parking Only	illumiance	Fc	1.48	3.3	0.2	7.40	16.50
Trespass	illumiance	Fc	0.02	0.5	0.0	N.A.	N.A.

OMNI-LITE, INC.	
203 WYNN STREET BURLINGTON MA 01803	
TYP# 781-272-2300, FAX # 781-272-0700 www.omnilitegip.com	
PROJECT:	
Winter Valley	
CLIENT:	
XXX	
SCALE:	FILE:
FEET	arni winter valley 00.acdm
DATE:	SALES PERSON:
11/18/2022	Sean Goiding
<i>THESE DRAWINGS ARE FOR CONCEPTUAL USE ONLY AND ARE NOT INTENDED FOR CONSTRUCTION. VALUES REPRESENTED ARE AN APPROXIMATION GENERATED FROM DATA SUPPLIED BY CAMP MIRE AND TESTING LABS.</i>	

DZ I Site Planning, Civil Engineering, Landscape Architecture
Po Box 307
Foxborough, MA
508.473.4114 phone
devellis@dzrein.com

DeVellis Zrein Inc.

11-21-22	LIGHT POLE ADJUSTMENTS
----------	------------------------

LIGHTING PLAN

SCALE:	1"=20'
JOB:	2GIS-455
FILE:	
DRAWN:	OMNI-LITE
CHECKED:	JJD
DATE:	11-04-22

C-6